


CLAIM MAP AMALGAMATED MINES COMPANY

BAKER CO. OREGON
SEC 35 & 36 T6S. R44E. SEC 12, 2 T7S. R44E. W.M.
SCALE 1" = 500'

Surveyed by IRA L. HOFFMAN Sept 21-26, 1915
Traced by H.K.L. C.V.M. Jan. 13, 1922

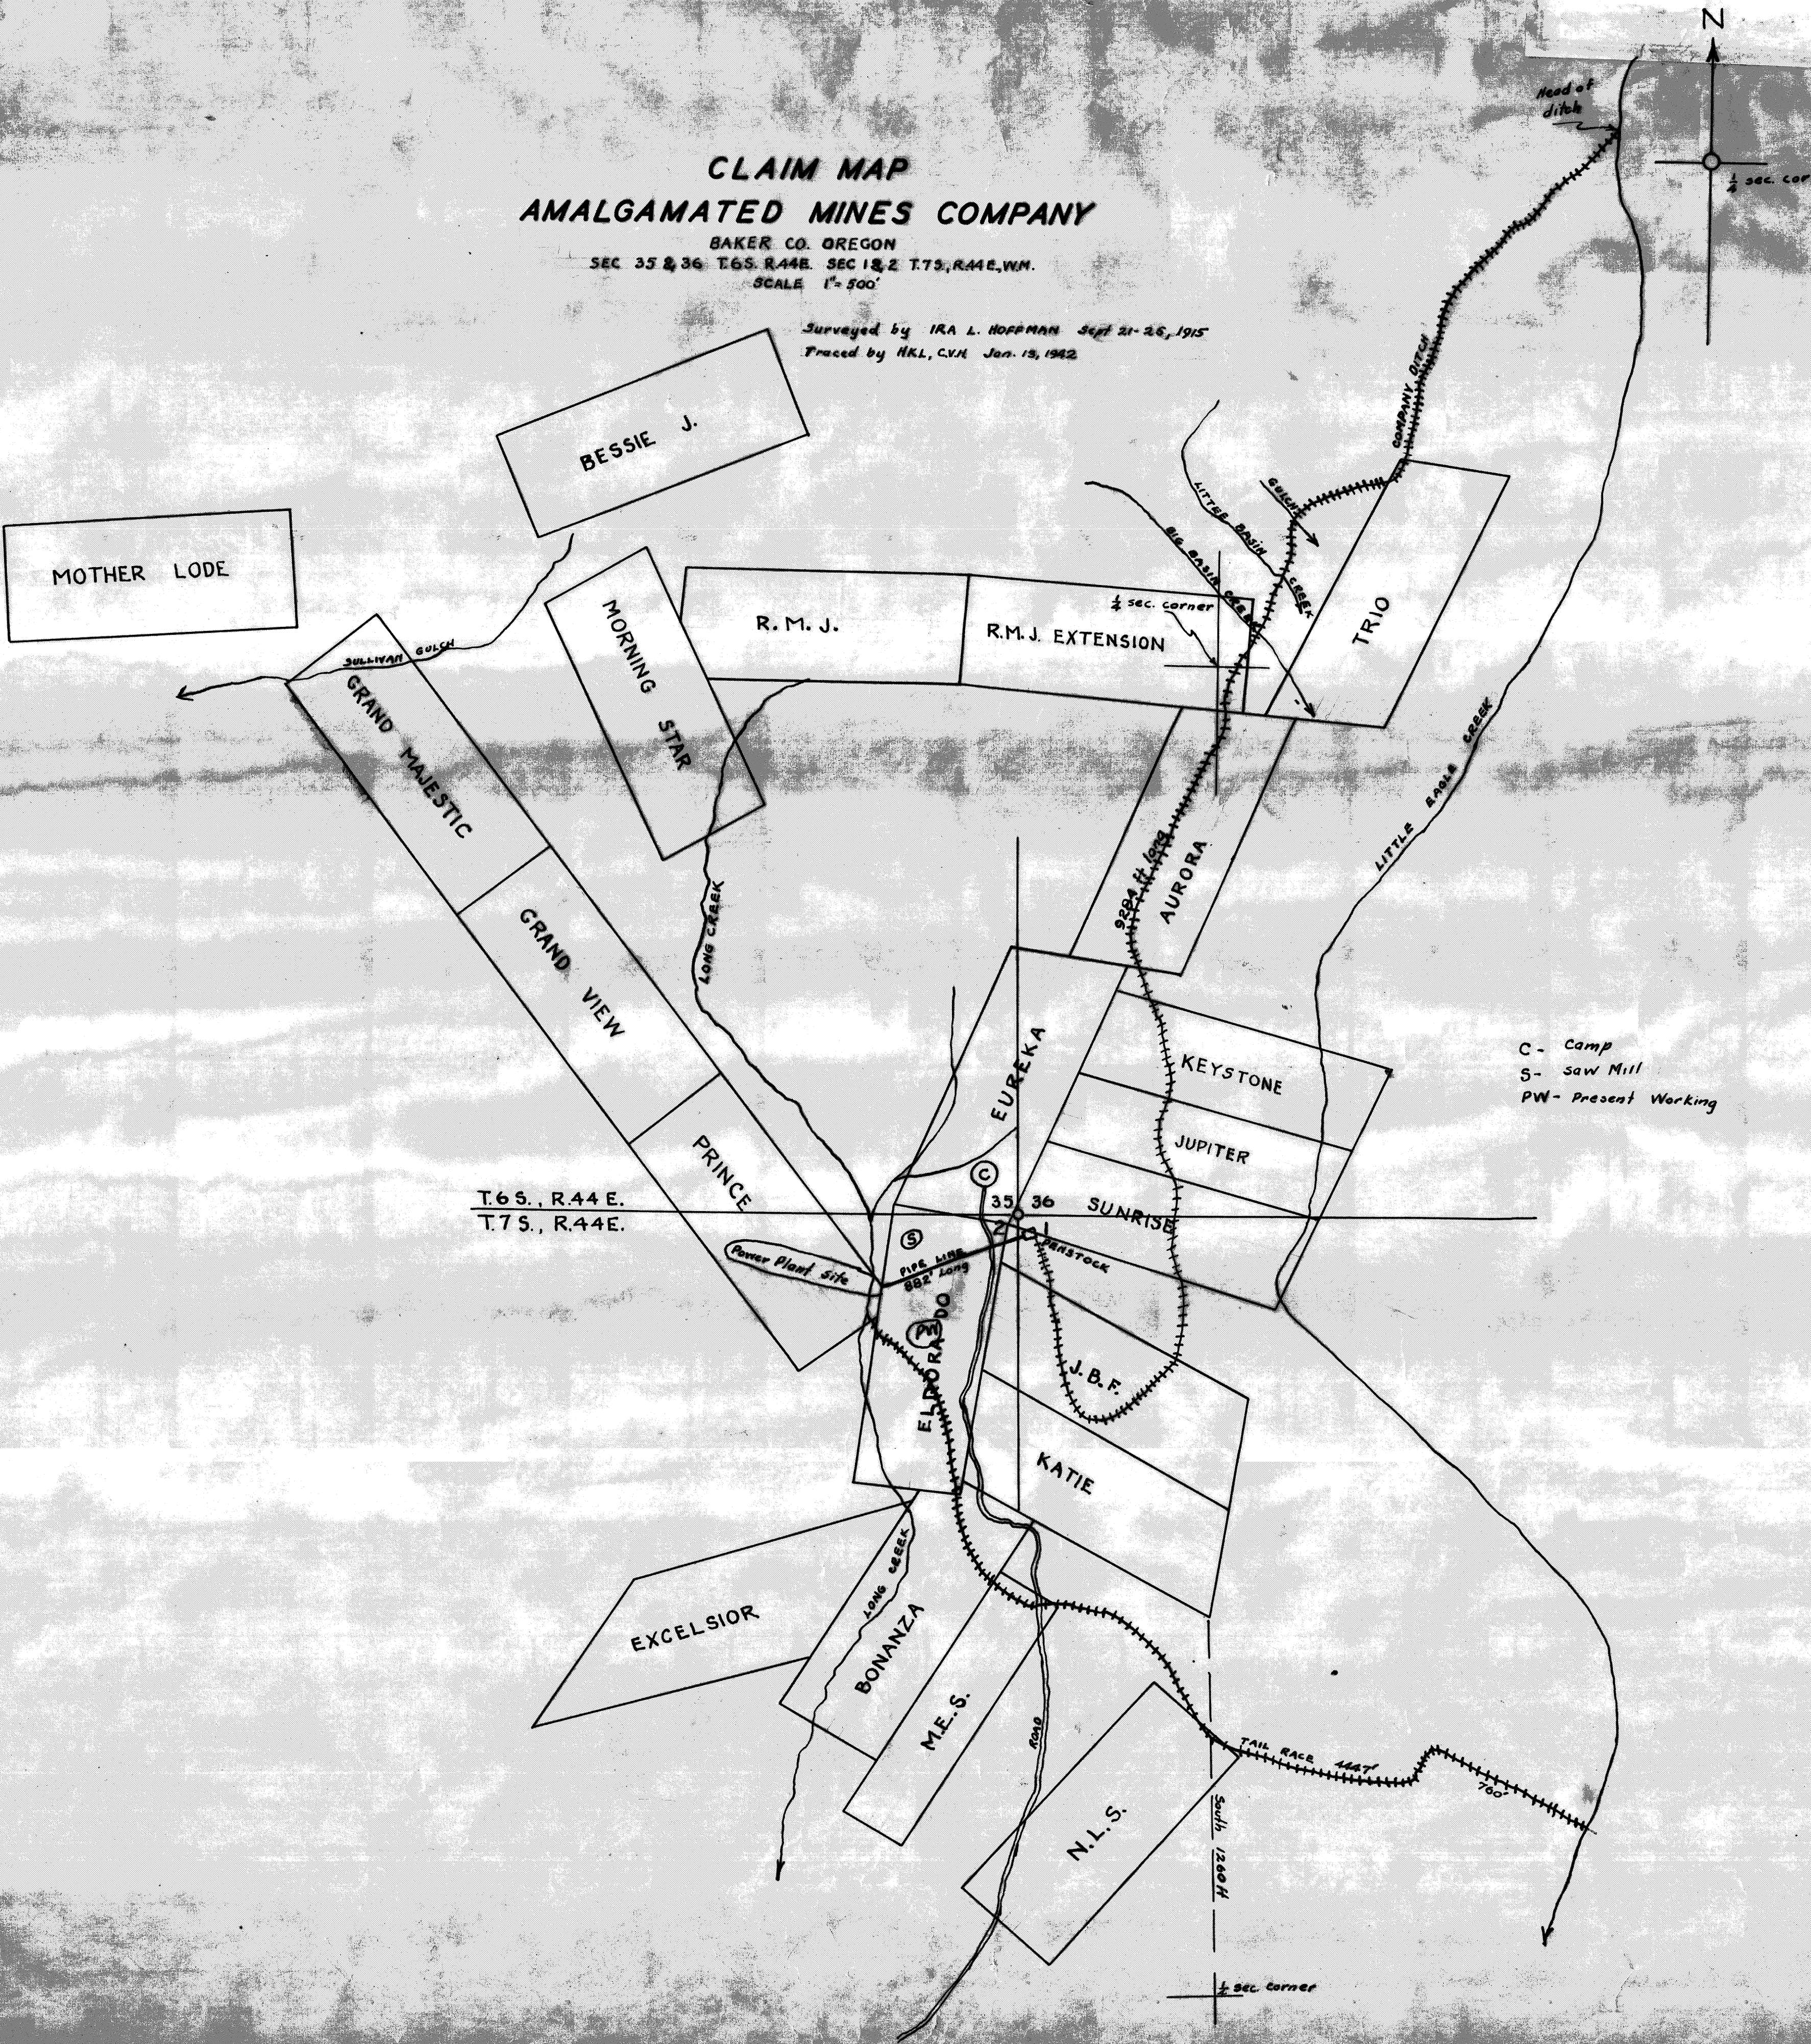

C - Camp
S - saw Mill
PW - Present Working

T.6S., R.44E.
T.7S., R.44E.

MOTHER LODE

BESSIE J.

MORNING STAR

R. M. J.

R.M.J. EXTENSION

TRIO

GRAND MAJESTIC

GRAND VIEW

PRINCE

AURORA

EUREKA

KEYSTONE

JUPITER

SUNRISE

J.B.F.

KATIE

EXCELSIOR

BONANZA

M.E.S.

N.L.S.

Power Plant site

PIPE LINE
882' Long

STENSTOCK

TAIL RACE 1447'

South 1260H

Head of ditch

1/4 sec. cor

1/4 sec. corner